



**ELECTRICAL - FIRST FLOOR PLAN**

SCALE: 1/8" = 1'-0"

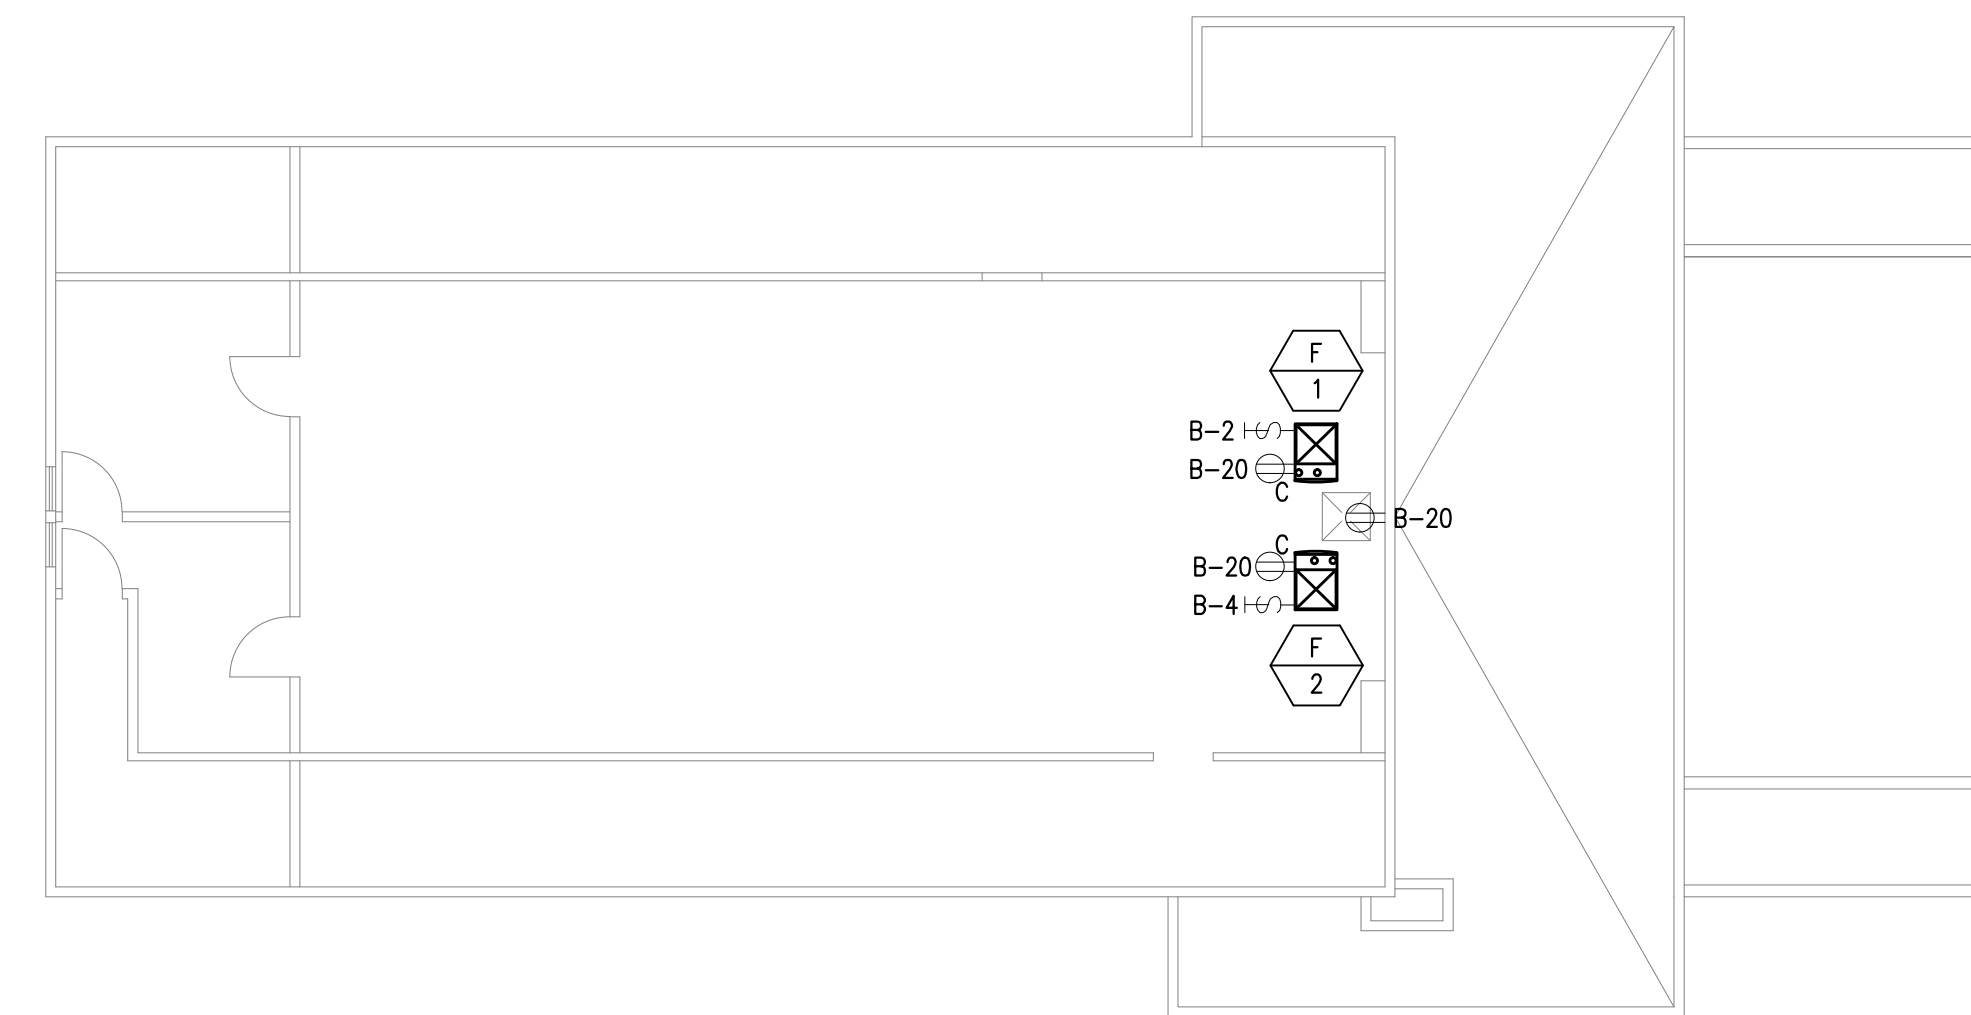

**ELECTRICAL - MEZZANINE FLOOR PLAN**

SCALE: 1/8" = 1'-0"

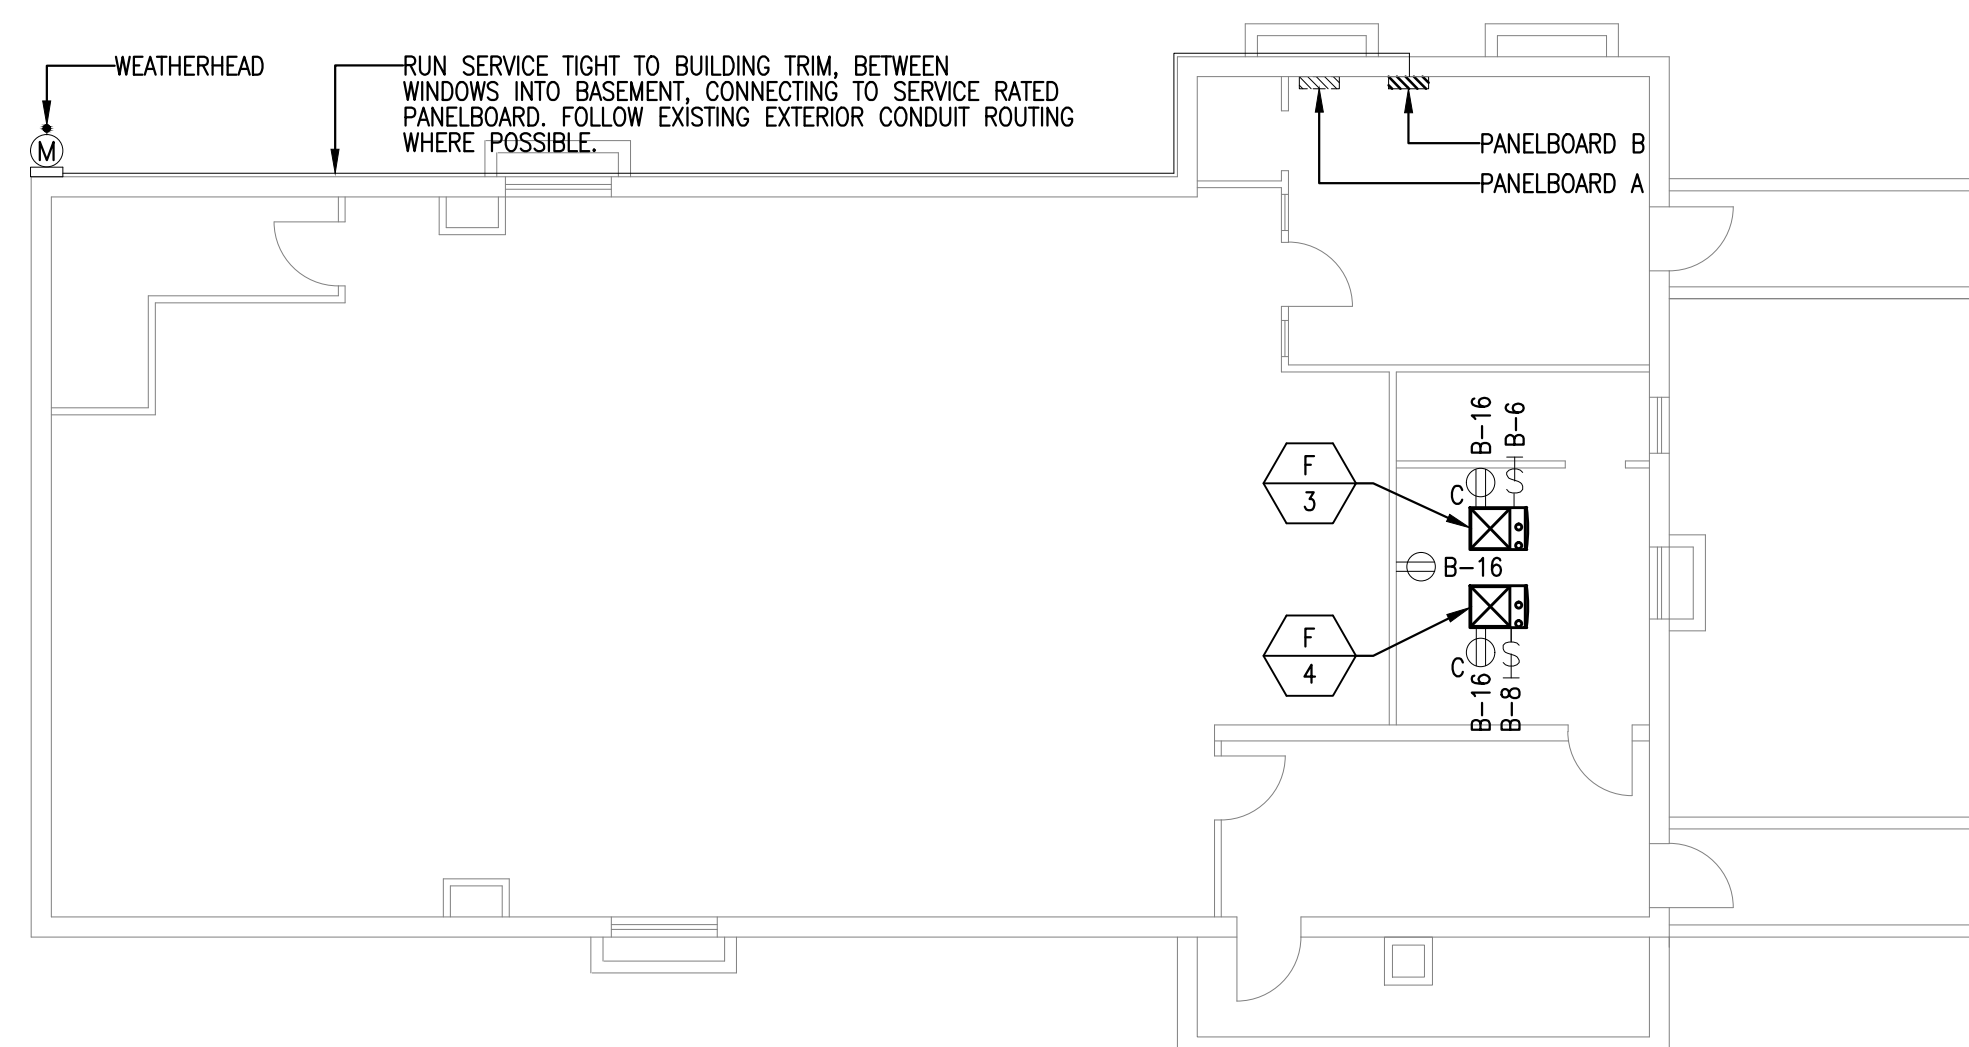

**ELECTRICAL - BASEMENT PLAN**

SCALE: 1/8" = 1'-0"

**GRIFFITH & VARY, INC.**  
 Consulting Engineers  
 12 Kendrick Road  
 Wareham, MA 02571  
 508-295-0050 (T)  
 508-295-0003 (F)  
 www.griffithandvary.com

**FREEDOM  
 HALL  
 FURNACE  
 REPLACEMENT**

Cotuit, MA

Notes:

North Arrow

Keyplan

Drawing Name:  
**ELECTRICAL  
 BASEMENT, FIRST,  
 AND MEZZANINE  
 FLOOR PLANS**

Scale: AS NOTED  
 Job No:  
 Drawn By: FZIII  
 Date: Sept. 16, 2013

Drawing Number:  
**E-2**