


MECHANICAL - PARTIAL BASEMENT PLAN GAS PIPING

SCALE: 1/4" = 1'-0"

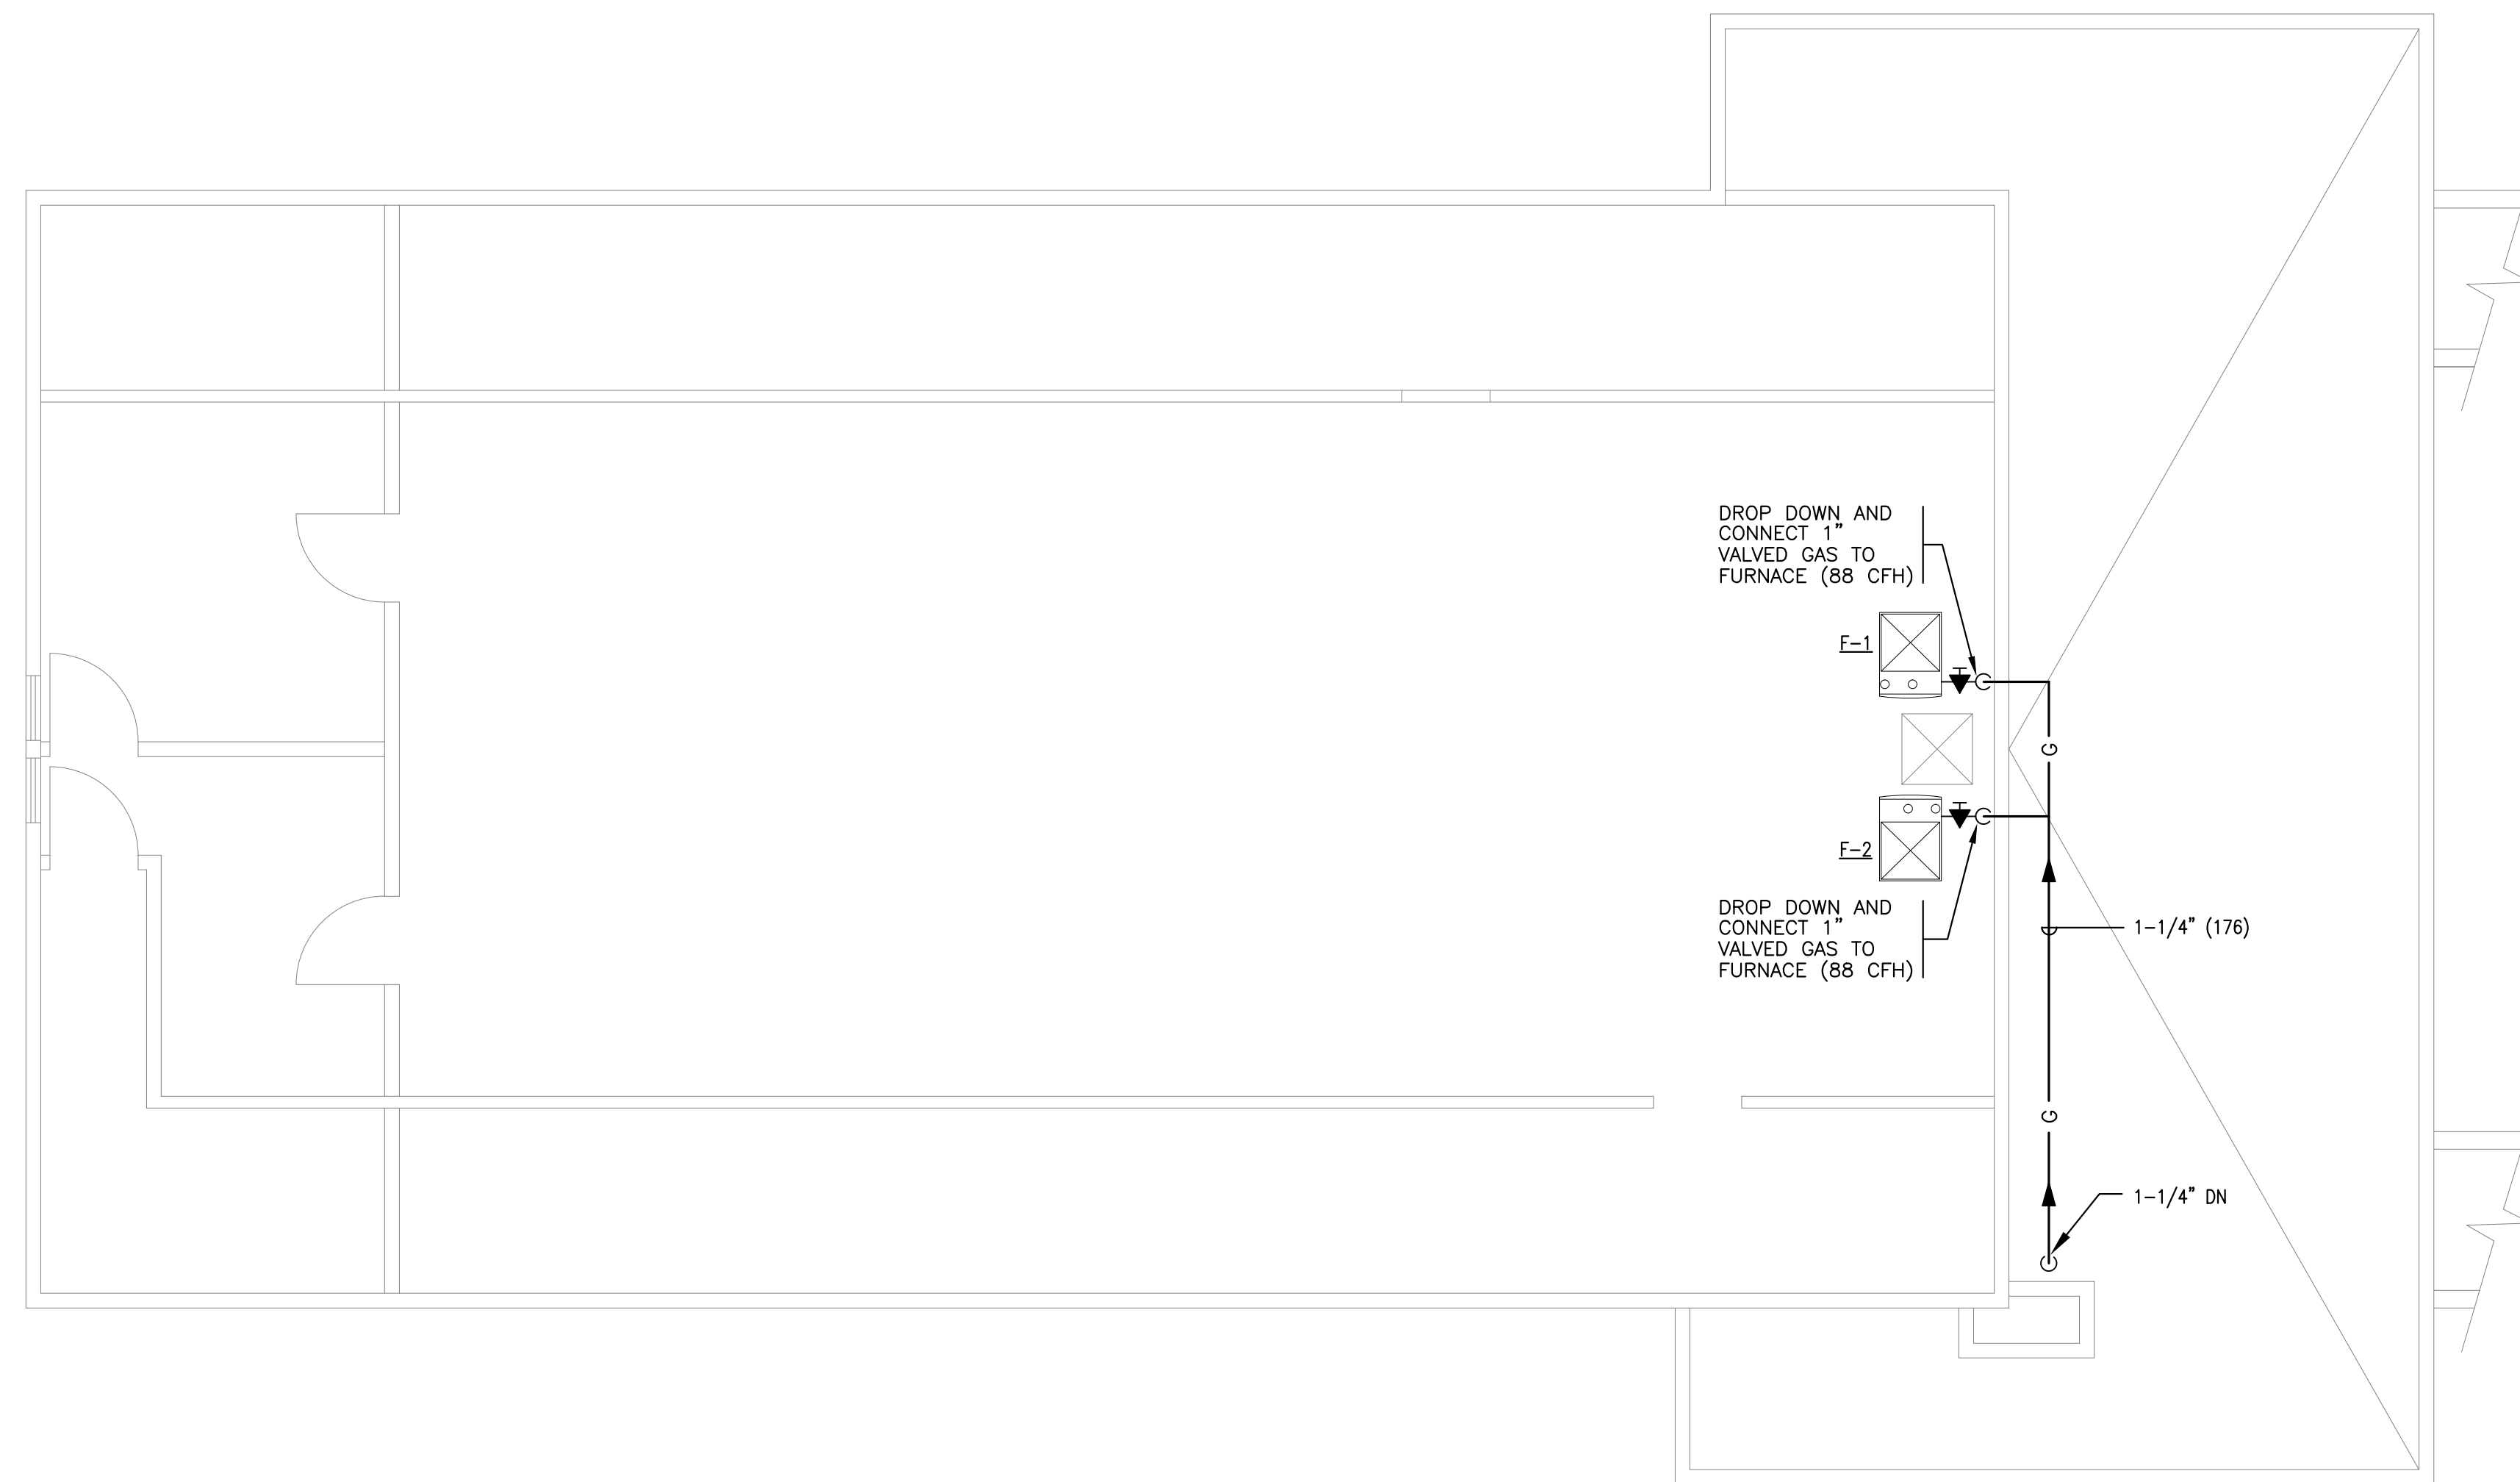

MECHANICAL - MEZZANINE GAS PIPING PLAN

SCALE: 1/4" = 1'-0"

GRIFFITH & VARY, INC.
 Consulting Engineers
 12 Kendrick Road
 Wareham, MA 02571
 508-295-0050 (T)
 508-295-0003 (F)
 www.griffithandvary.com

**FREEDOM
 HALL
 FURNACE
 REPLACEMENT**
 Cotuit, MA

Notes:

North Arrow

Keyplan

Drawing Name:
**PLUMBING
 BASEMENT AND
 MEZZANINE
 GAS PIPING PLANS**

Scale: AS NOTED
 Job No:
 Drawn By: TEP
 Date: Sept. 16, 2013

Drawing Number:
P-1